


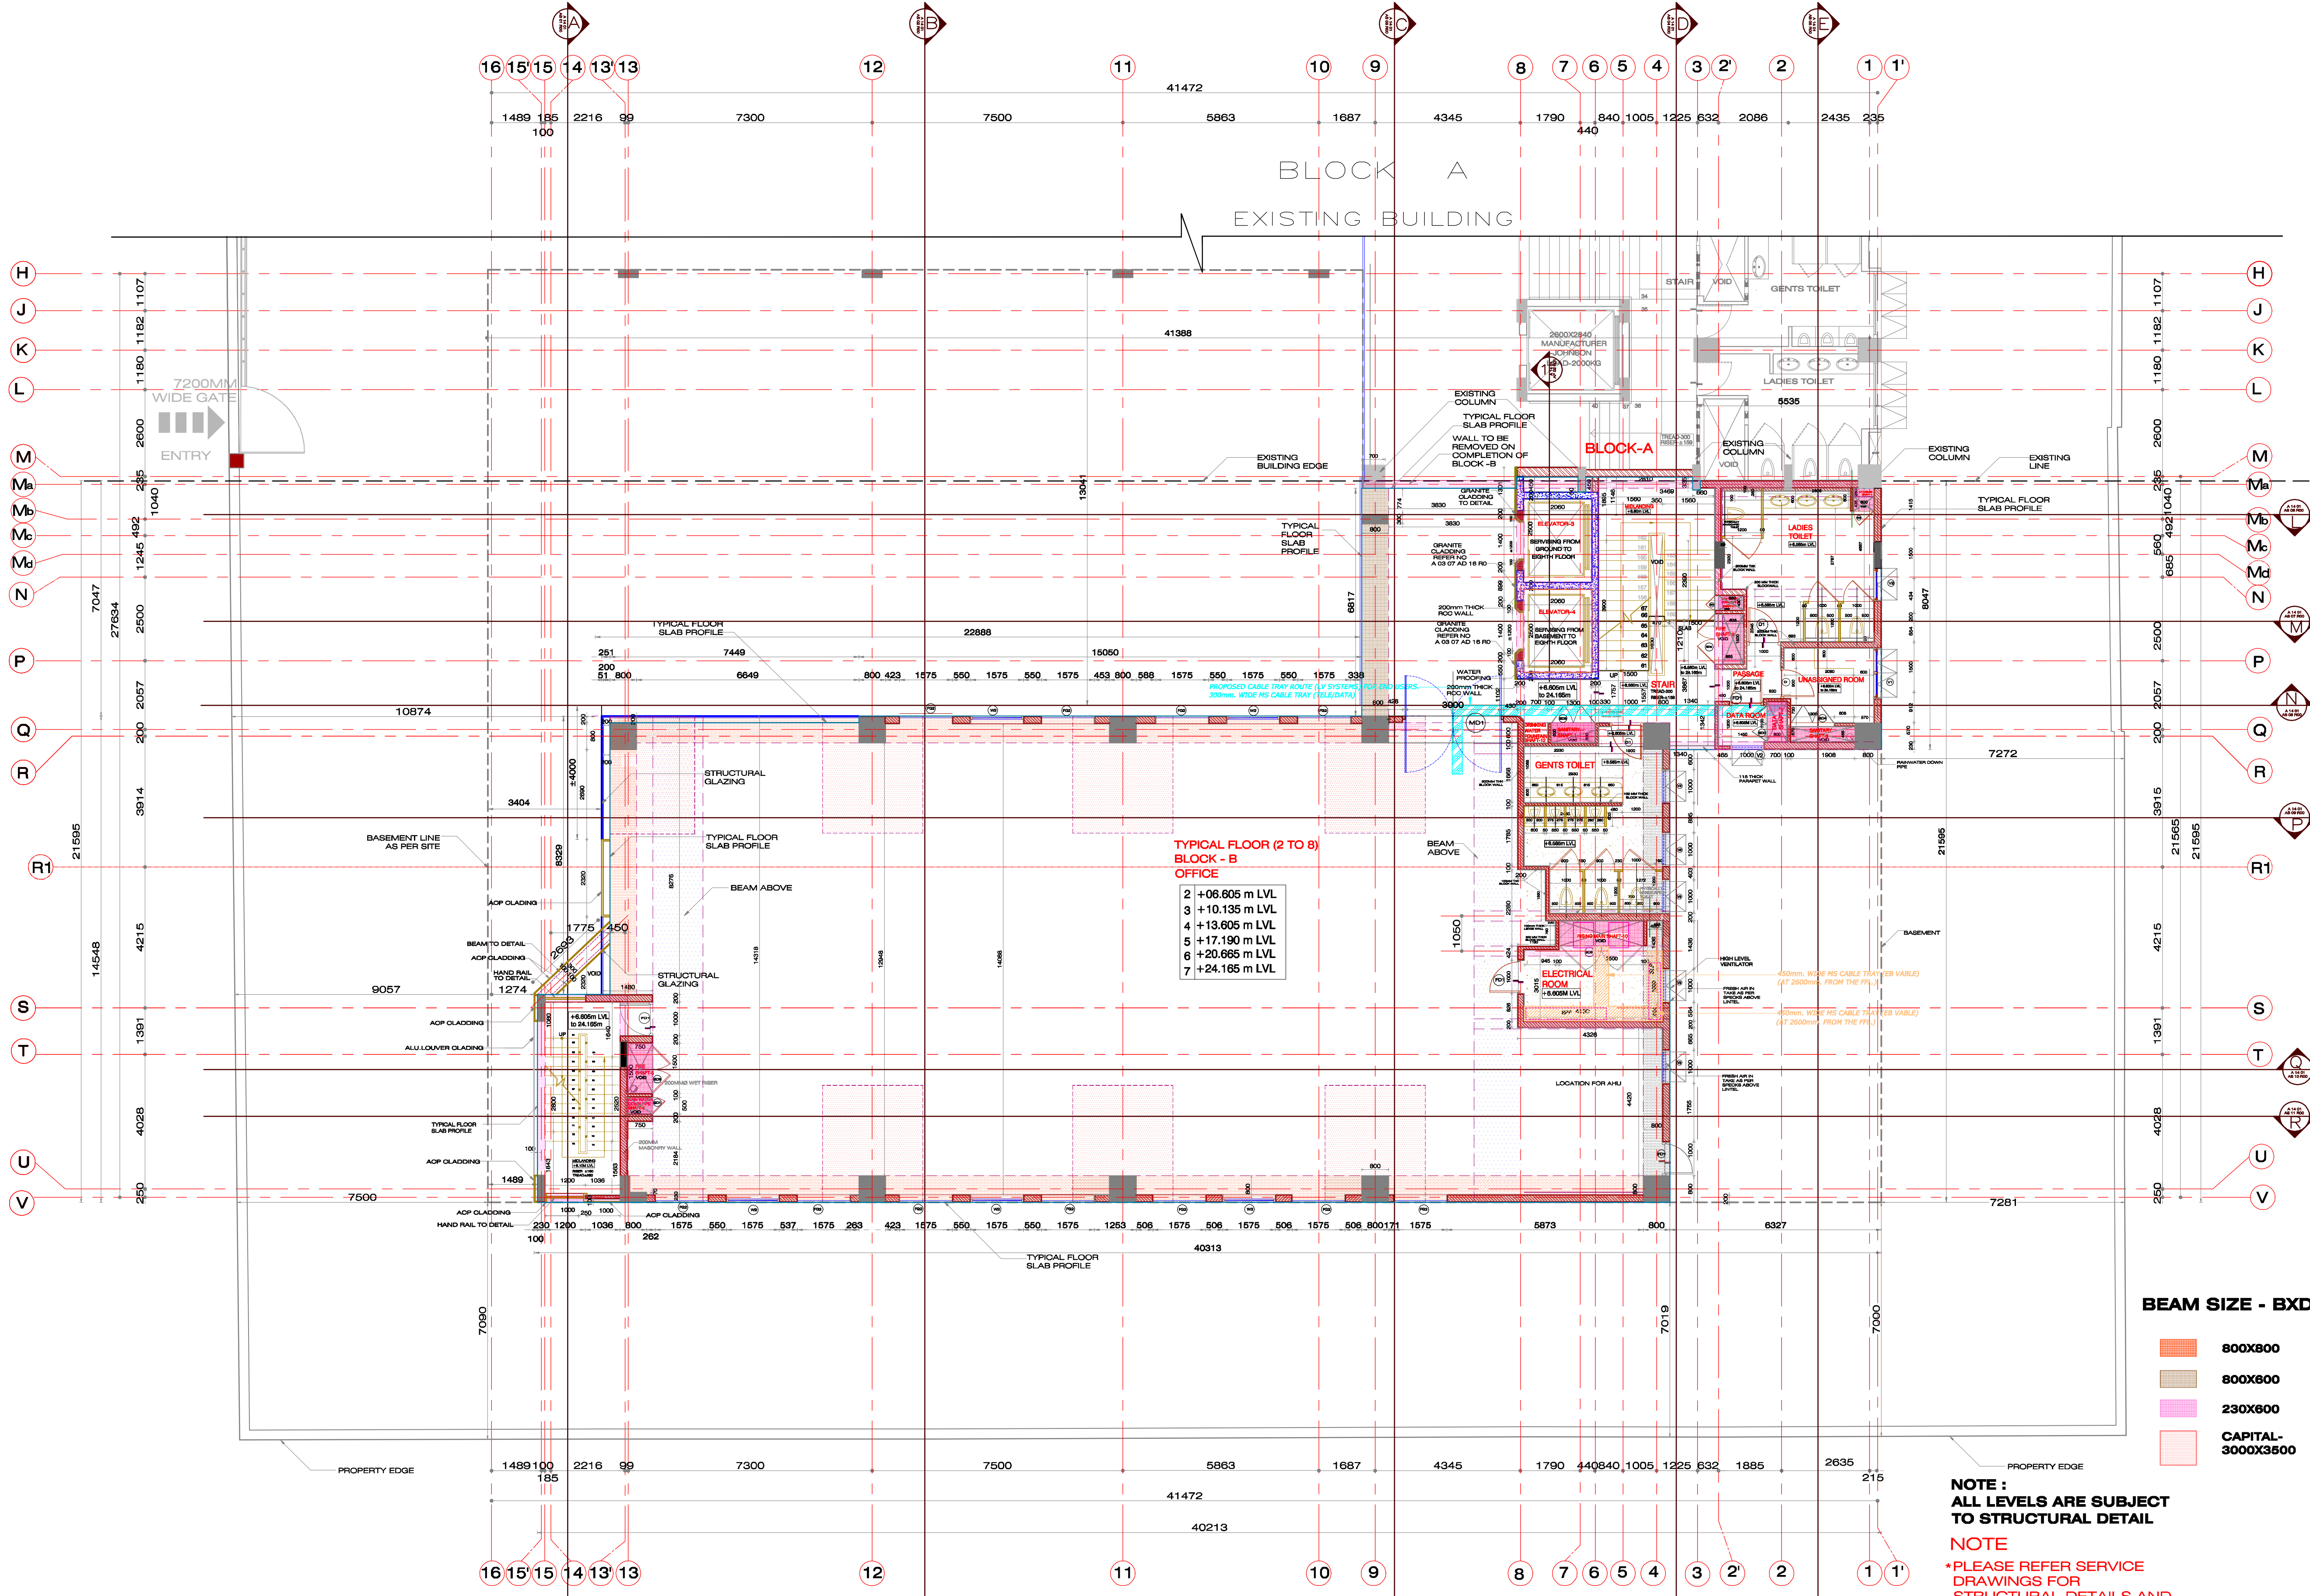

TYPICAL FLOOR PLAN (2 TO 7)

SL.NO	DATE	NAME	REVISION	SL.NO	DATE	NAME	REVISION	SL.NO	DATE	NAME	REVISION
01	30.12.2014	NISHA	A NEW COLUMN WAS ADDED IN THE ELECTRICAL ROOM. 300MM SQUARE COLUMN TO BE ADDED IN ELECTRICAL ROOM. 300MM SQUARE COLUMN TO BE ADDED IN ELECTRICAL ROOM.	06	21.03.2015	NISHA	ALL WALLS 200 RPTV CHANGE	10	21.11.2015	NISHA	LOCATION FOR AHU ROOM AREA CHANGE
02	05.02.2015	NISHA	MANUFACTURING CORRECTION	07	03.04.2015	NISHA	LADIES TOILET/PANTRY STORE DOOR CHANGE, AHU ROOM CHANGE,	11	05.01.2016	NISHA	MAIN STAIRCASE AREA LEVELS CHANGED
03	25.01.2015	NISHA	ELECTRICAL ROOM ADDED, ELECTRICAL ROOM CHANGED INTO PANTRY/STORE	08	22.05.2015	NISHA	LADIES TOILET/GENTS TOILET PARTITION WALL CHANGE				
04	02.03.2015	NISHA	THE DEPTH OF THE SHIRT CHANGED FROM 800MM TO 700MM IN ELECTRICAL ROOM	09	30.06.2015	SHANMATHI	LADIES TOILET VENTILATOR CHANGED ELECTRICAL ROOM DOOR SIZE CHANGED				
CLIENT											
PRAMOD MADHAVAN						SINTRON ELECTRONICS PVT LTD — PHASE 3					
ARCHITECT						TITLE					
DRAWN						WORKING DRAWING — TYPICAL FLOOR (2 TO 7) — REVISED AS PER SITE SETBACK (SHOWING WITH STRUCTURE)					
DATE						PRINT STATUS:					
SCALE						☐ SCHEMATIC					
CHECKED						☒ APPROVED FOR CONSTRUCTION					
THIS DRAWING IS THE PROPERTY OF M/S. KECHA ARCHITECTURE & INTERIOR ARCHITECTURE, AND ITS USE IN ANY MANNER, OTHER THAN FOR WHAT IT HAS BEEN ISSUED FOR, IS PROHIBITED.						DRAWING NO.					
						A 14_01_03					
						11					

<